

# ASHRAE HEADQUARTERS ADDITION AND RENOVATION



THIS DRAWING IS THE PROPERTY OF RICHARD WITTGENBERG ASSOCIATES, INC. AND IS TO BE USED ONLY FOR THE PROJECT AND SITE SPECIFICALLY IDENTIFIED HEREON. IT IS NOT TO BE REPRODUCED, COPIED, OR TRANSMITTED IN ANY FORM OR BY ANY MEANS, ELECTRONIC OR MECHANICAL, INCLUDING PHOTOCOPYING, RECORDING, OR BY ANY INFORMATION STORAGE AND RETRIEVAL SYSTEM, WITHOUT THE WRITTEN PERMISSION OF RICHARD WITTGENBERG ASSOCIATES, INC.

DRAWING TITLE:

SECOND FLOOR  
POWER PLAN


PROJECT NUMBER:  
200614

DATE:  
05/25/07


DRAWING NUMBER:  
E3.20



270 Scientific Drive  
Norcross, Georgia, 30092  
770.441.7711  
Technology Park/Atlanta

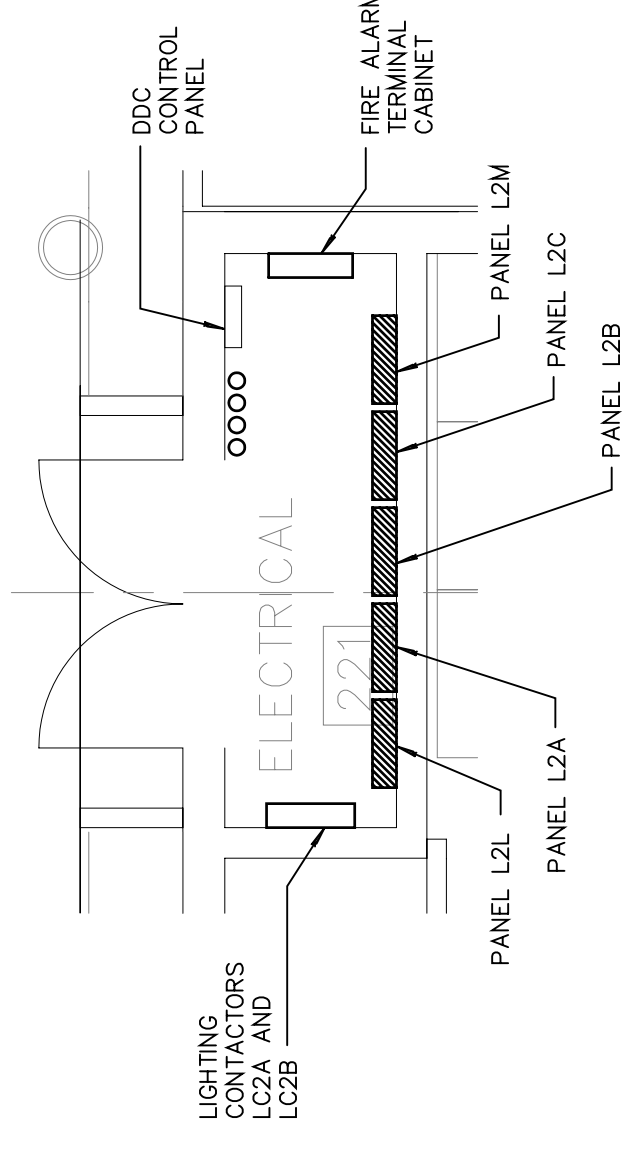

2 ENLARGED ELECTRICAL ROOM  
SCALE: 1/4" = 1'-0"

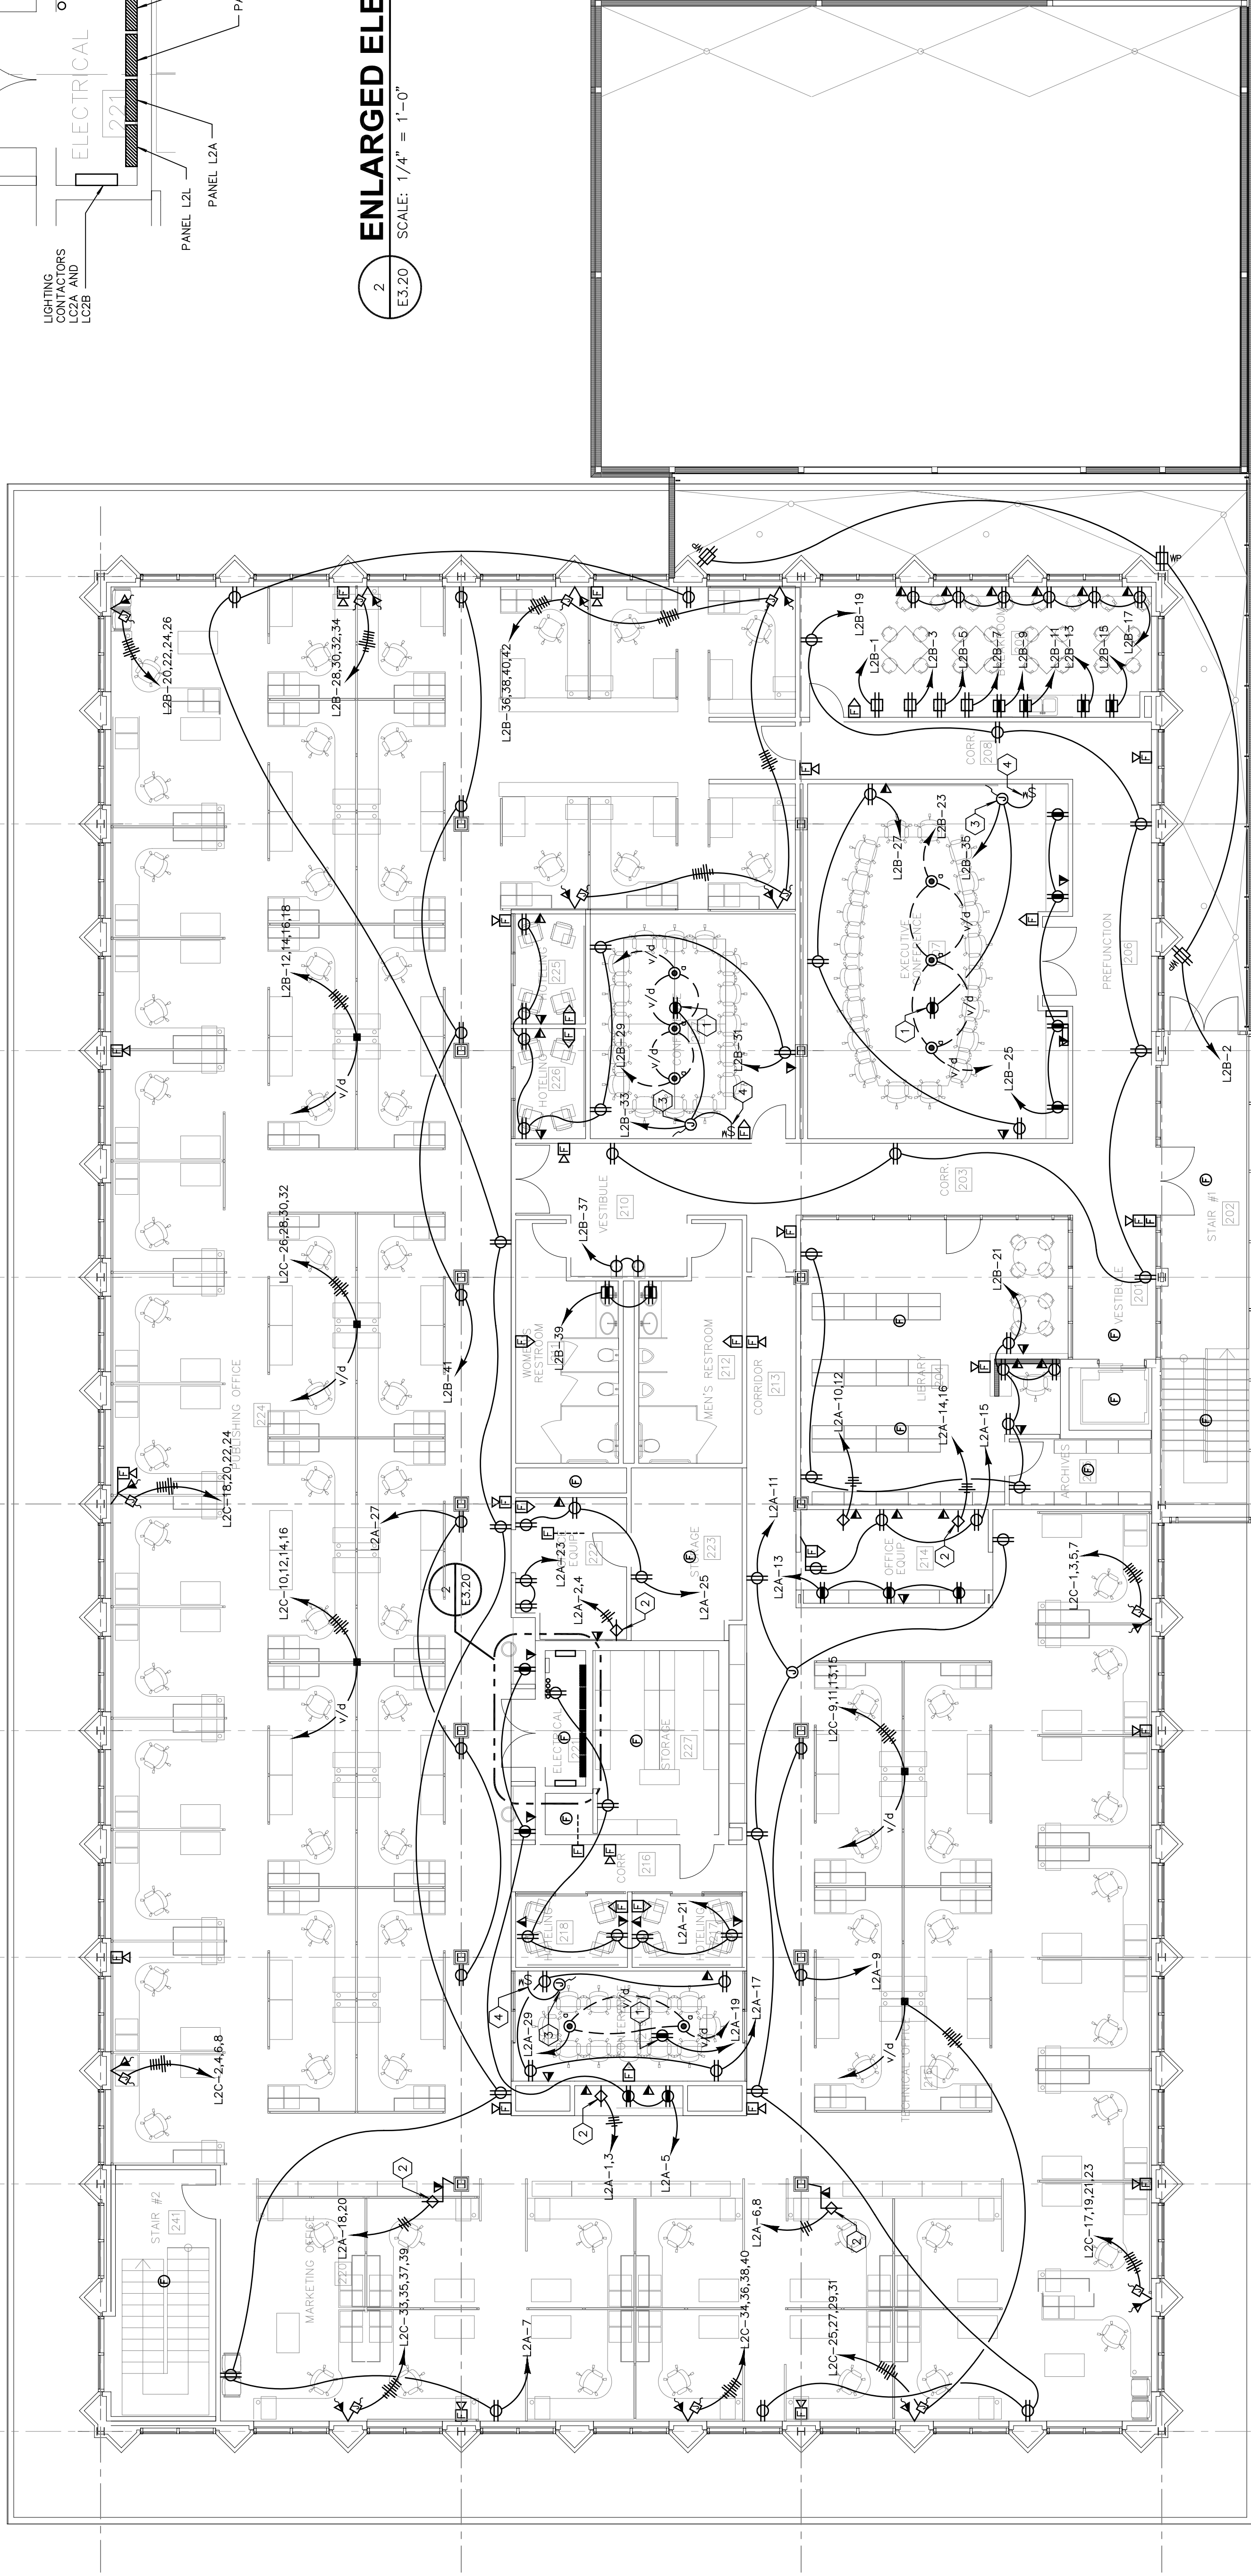

1 SECOND FLOOR POWER PLAN  
SCALE: 1/8" = 1'-0"

### KEYNOTES:

- 1 RECEPTACLE MOUNTED AT ACCESSIBLE CEILING FOR FUTURE CEILING MOUNTED PROJECTOR. COORDINATE EXACT LOCATION WITH ARCHITECT PRIOR TO ROUGH-IN.
- 2 COORDINATE EXACT CONNECTION TYPE AND LOCATION WITH ARCHITECT PRIOR TO ROUGH-IN.
- 3 JUNCTION BOX MOUNTED ABOVE ACCESSIBLE CEILING FOR POWER CONNECTION TO MOTORIZED SCREEN. COORDINATE EXACT LOCATION WITH ARCHITECT PRIOR TO ROUGH-IN.
- 4 SWITCH FOR CONTROL OF MOTORIZED SCREEN. COORDINATE EXACT LOCATION WITH ARCHITECT PRIOR TO ROUGH-IN.

### GENERAL NOTES:

1. REFER TO ARCHITECTURAL DRAWING FOR LOCATIONS OF DEVICES. IF CONFLICTING LOCATIONS ARE INDICATED, ARCHITECT LAYOUT TAKES PRECEDENCE.